


S. MISSION ROAD

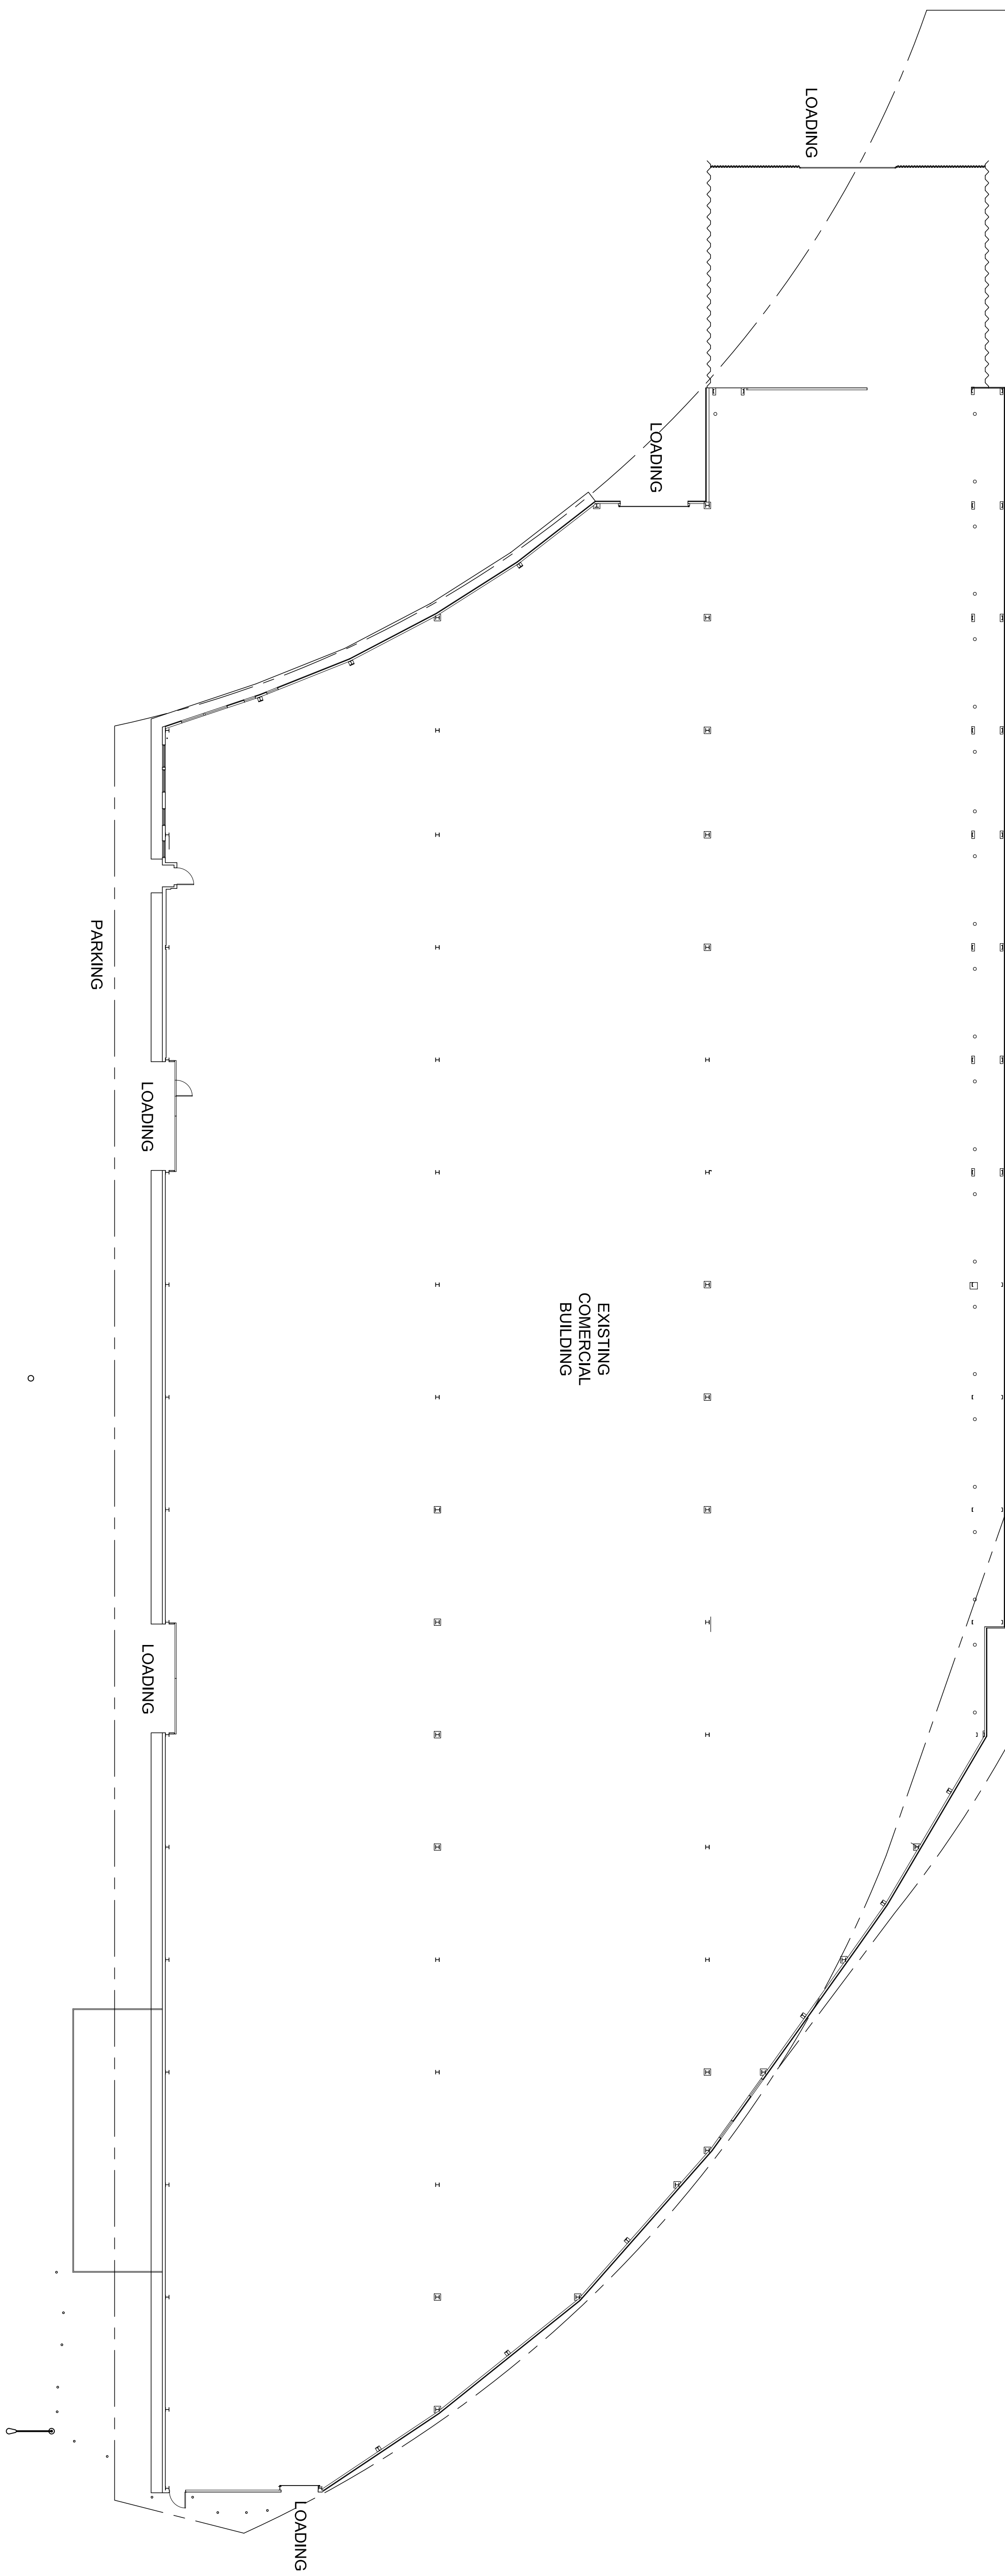

NOTE:
 PREPARED FOR REFERENCE
 PURPOSES ONLY AND SHOULD NOT BE
 USED, AND IS NOT INTENDED FOR
 SURVEY OR ENGINEERING PURPOSES.

SHEET NO.
A-1.0
 1 of 5 sheets

Date: 08/17/2015
 Drawn by: R. Wrightson
 T. Kelly, N. Dermand
 Approved by: M.C.
 Job Number: 1384-15
 File Name:
 205 S Mission.dwg



SHEET TITLE:
 Site Plan

PROJECT INFO:
 205 S. Mission Road
 Los Angeles, CA 90033

205 S. Mission Road

CLIENT:
 3 STEEL LLC
 337 S. Andersen St.
 Los Angeles, CA 90033



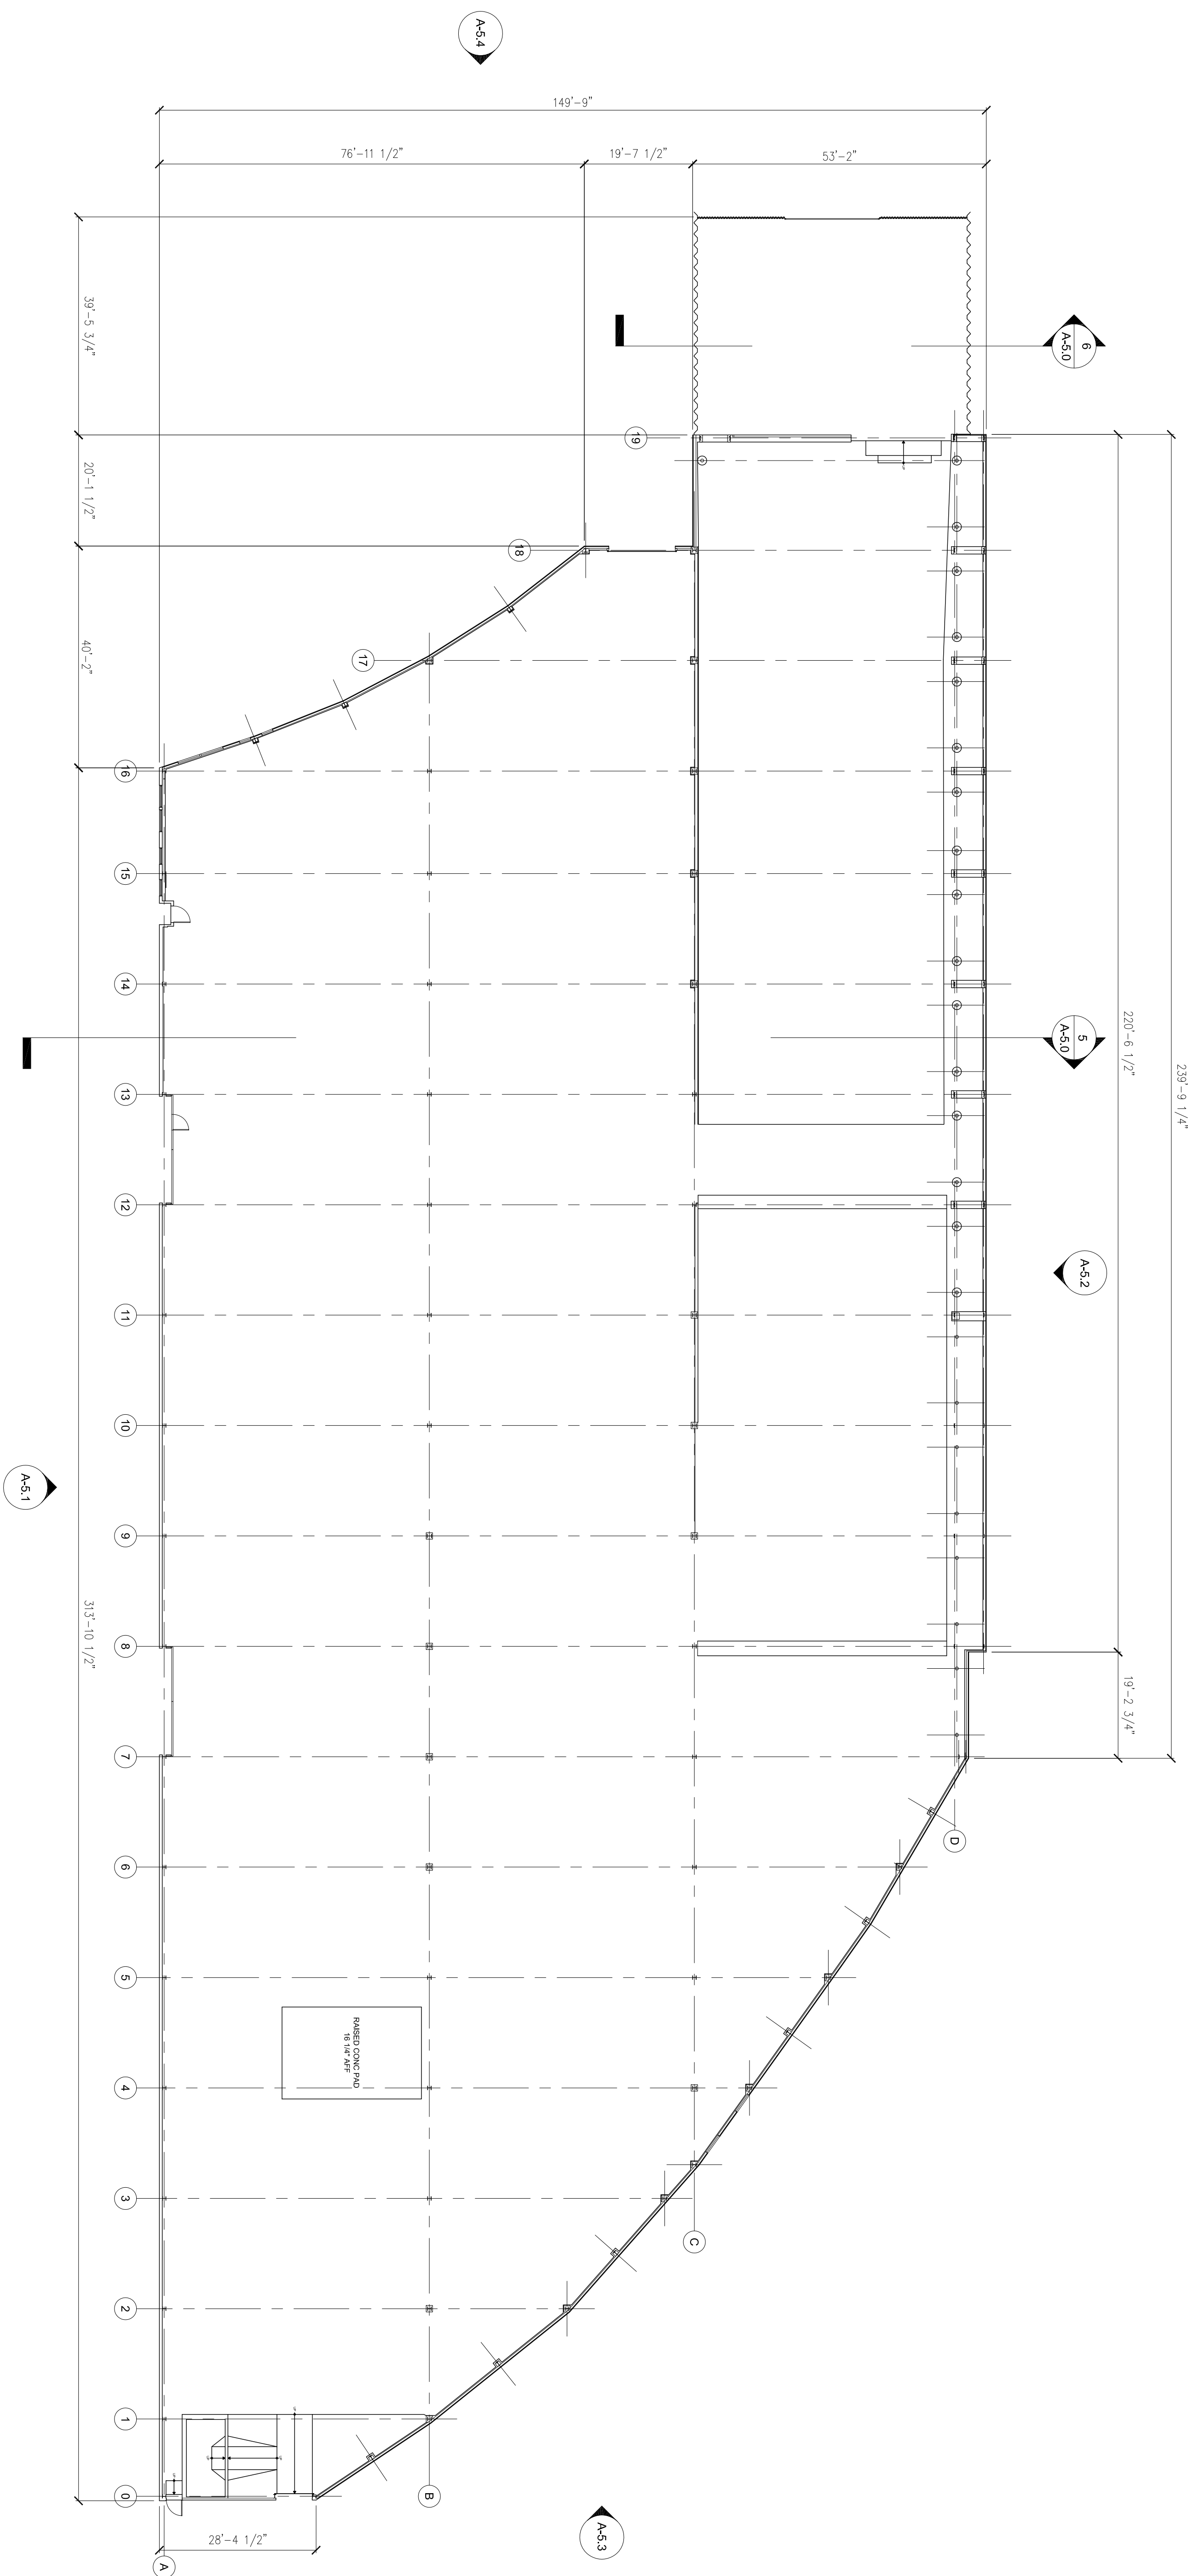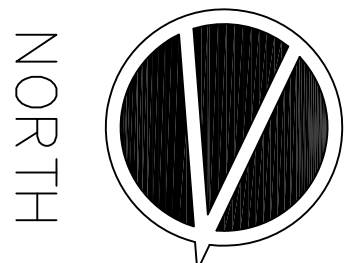

SHEET NO.
A-2.0
 2 of 5 sheets



Date: 08/17/2015
 Drawn by: R. Wrightson
 T. Kelly, N. Dermand
 Approved by: M.C.
 Job Number: 1384-15
 File Name:
 205 S Mission.dwg

SHEET TITLE:
 Floor Plan

PROJECT INFO:
 205 S. Mission Road
 205 -251 S. Mission Road
 Los Angeles, CA 90033

CLIENT:
 3 STEEL LLC
 337 S. Andersen St.
 Los Angeles, CA 90033



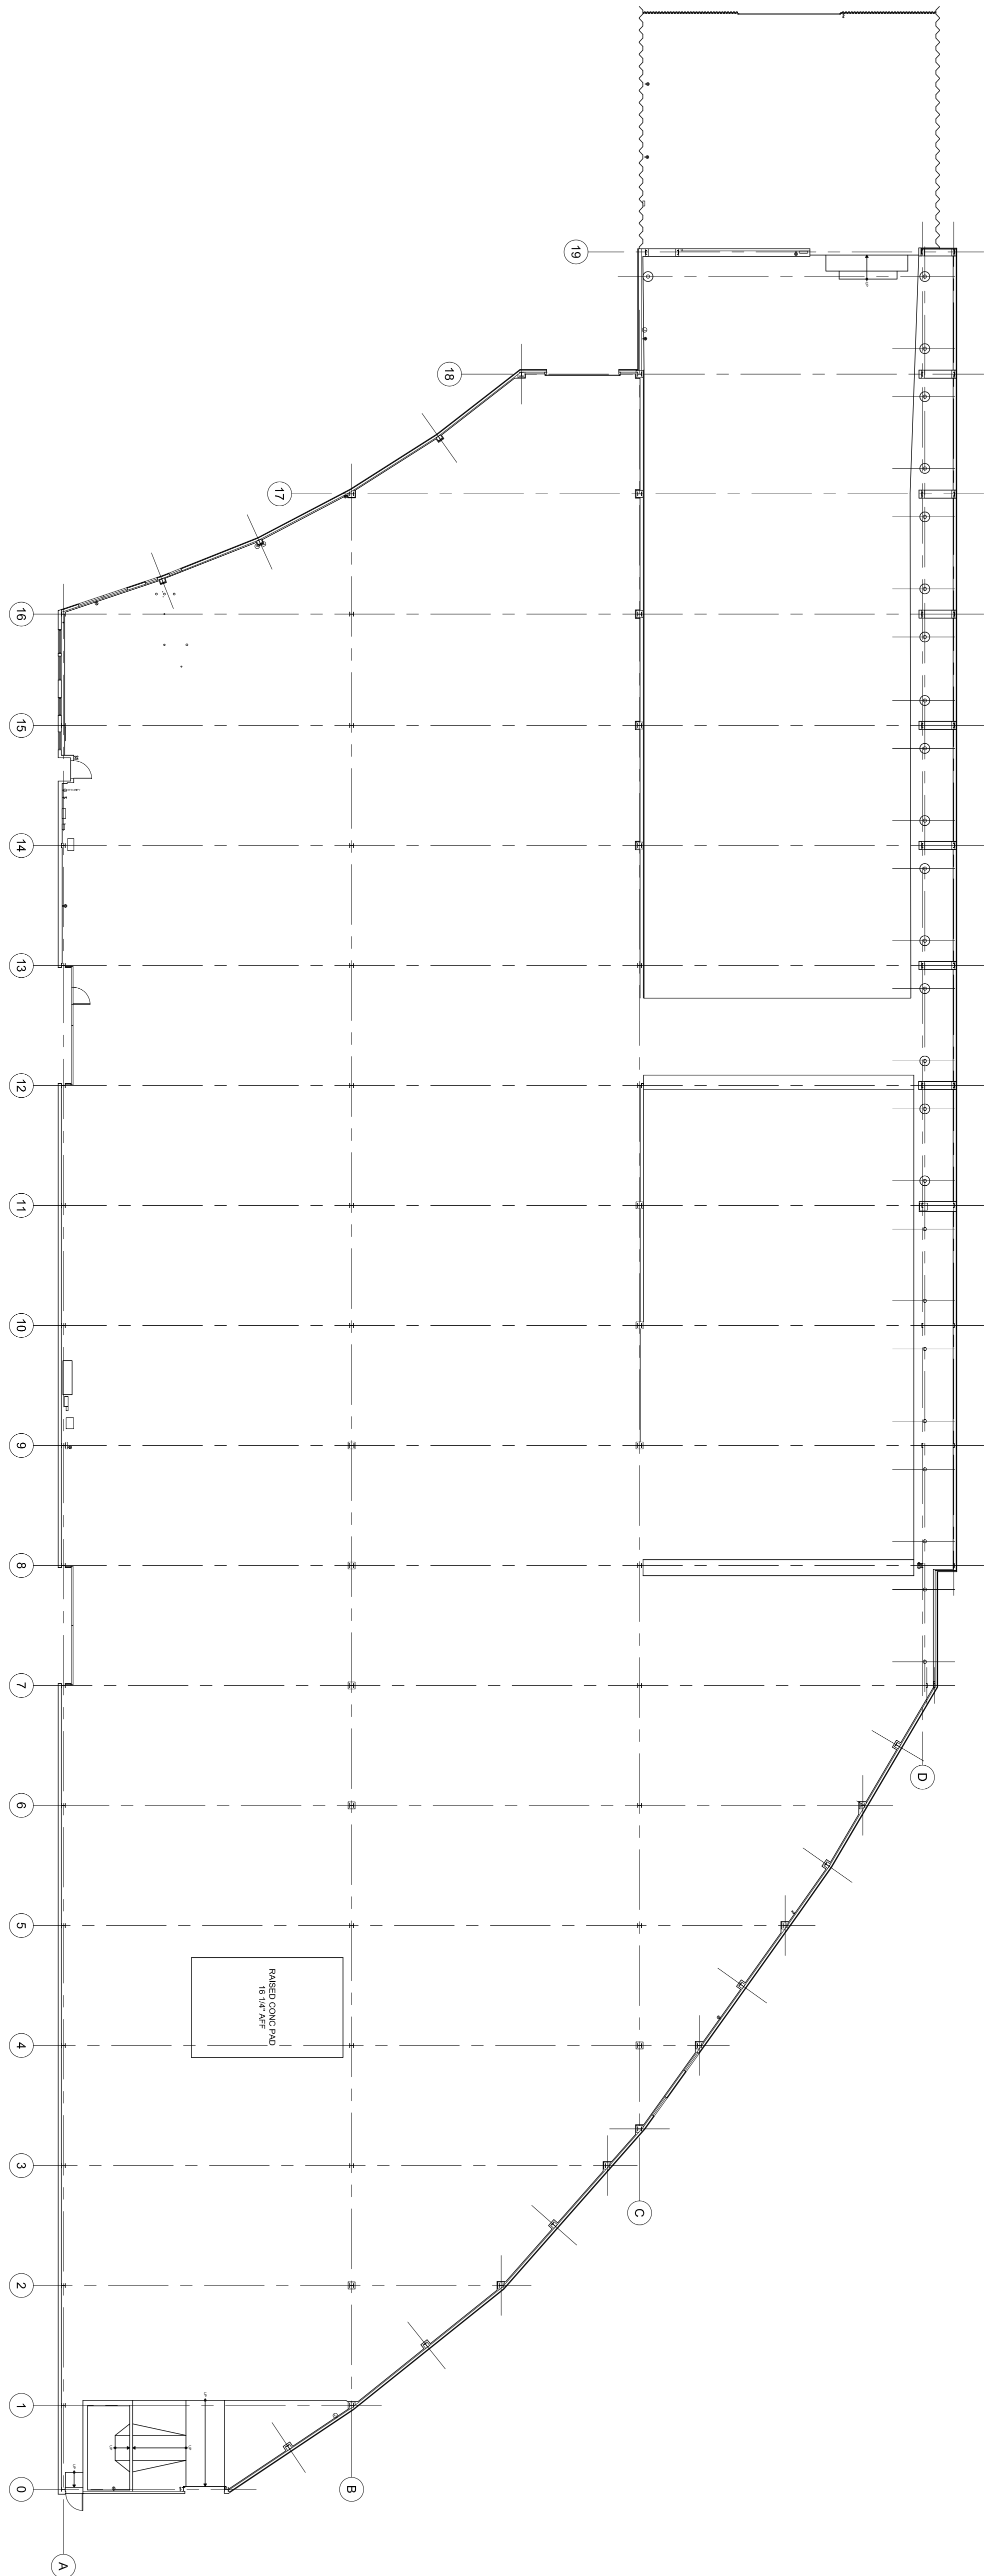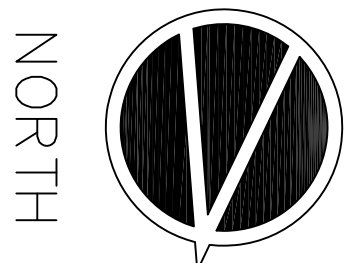

- LEGEND**
- ⊗ Light Switch
 - ⊙ Wall Mounted Duplex Outlet
 - ⊠ Floor Mounted Duplex Outlet
 - ⊡ Telephone
 - ⊣ In-House Communication System
 - Cable
 - ⊖ Thermal
 - ⊕ Smoke Detector
 - ⊕ Junction Box
 - ⊕ Dispersal
 - ⊕ Electrical Panel
 - ⊕ Exit Sign

SHEET NO.
A-3.0
3 of 5 sheets

Date: 08/17/2015
 Drawn by: R. Wrightson
 T. Kelly, N. Dermand
 Approved by: M.C.
 Job Number: 1384-15
 File Name:
 205 S Mission.dwg

SHEET TITLE:
Electrical Plan


PROJECT INFO:
 205 S. Mission Road
 205 -251 S. Mission Road
 Los Angeles, CA 90033

CLIENT:
 3 STEEL LLC
 337 S. Andersen St.
 Los Angeles, CA 90033




Reflected Ceiling Plan

Scale: 1/16" = 1'-0"

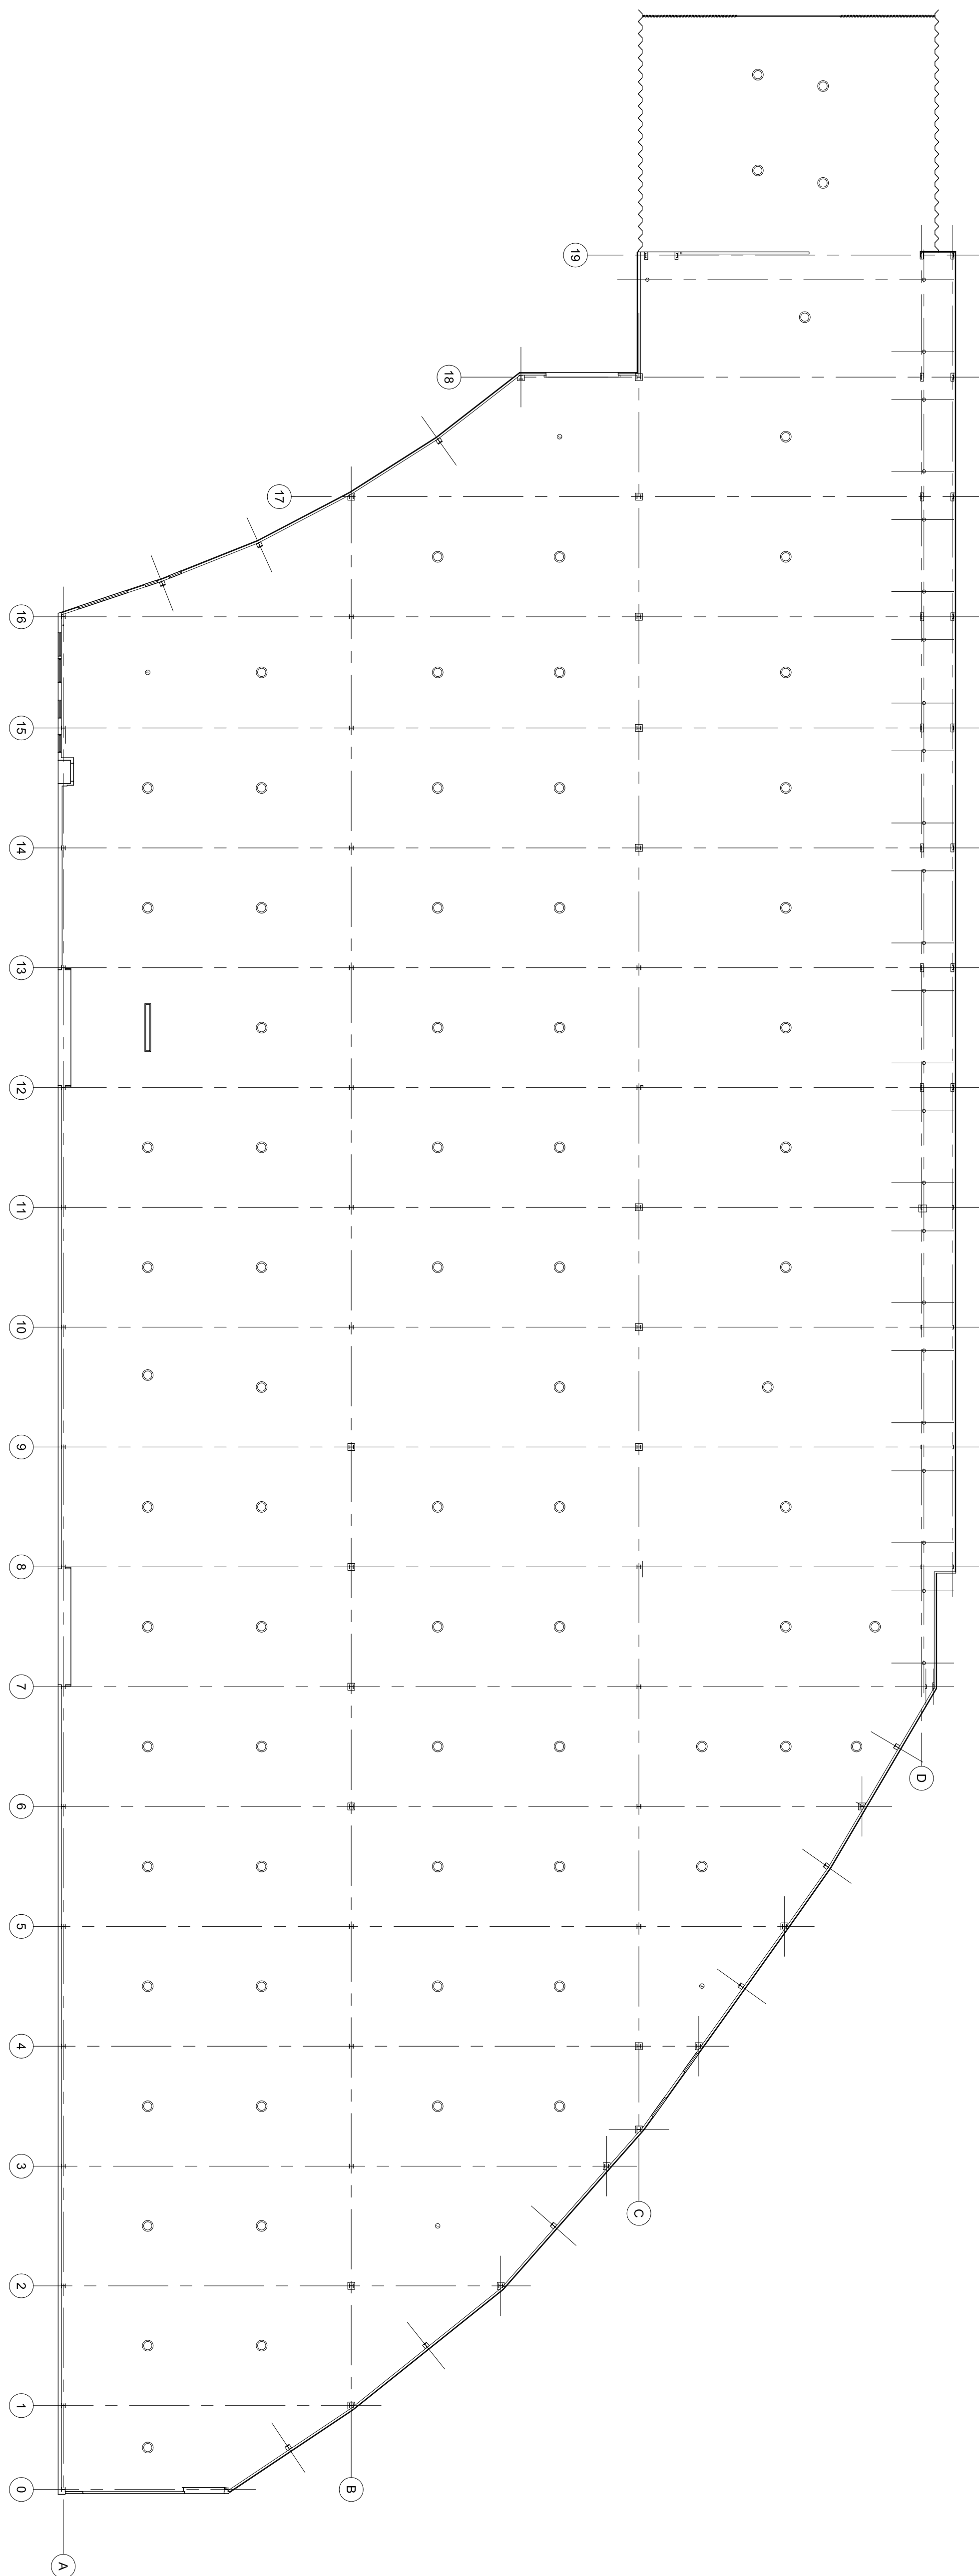

- LEGEND**
- Downlight / Pendant
 - Surface-Mounted Light Fixtures
 - Supply Register
 - Exhaust Vent
 - Motion Detector
 - Vacuum Tubes
 - v.a.c.

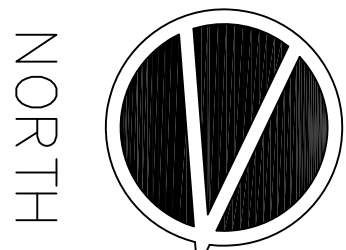

SHEET NO.
A-4.0
4 of 5 sheets


Date: 08/17/2015
 Drawn by: R. Wrightson
 T. Kelly, N. Dermand
 Approved by: M.C.
 Job Number: 1384-15
 File Name:
 205 S Mission.dwg

SHEET TITLE:
Reflected Ceiling Plan


PROJECT INFO:
205 S. Mission Road
 205 -251 S. Mission Road
 Los Angeles, CA 90033

CLIENT:
3 STEEL LLC
 337 S. Andersen St.
 Los Angeles, CA 90033


PrecisionCAD
 354 South Spring Street, Suite 202
 Los Angeles, CA 90013
 213-620-0635
 info@precisioncad.net
 www.precisioncad.net

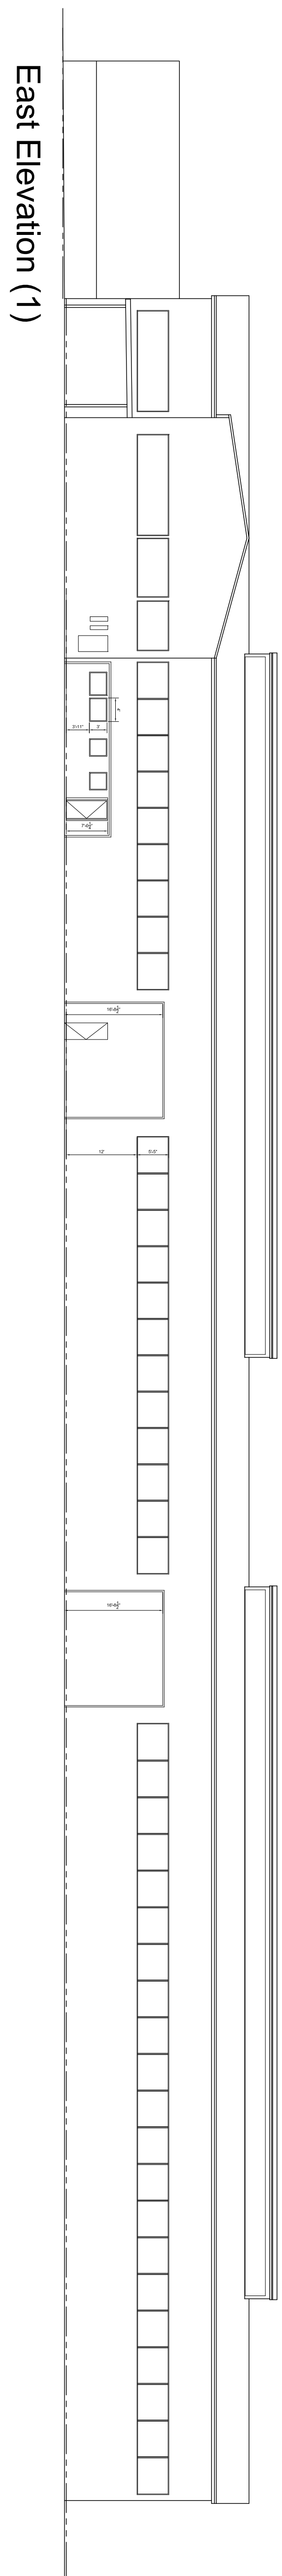


East Elevation (1)

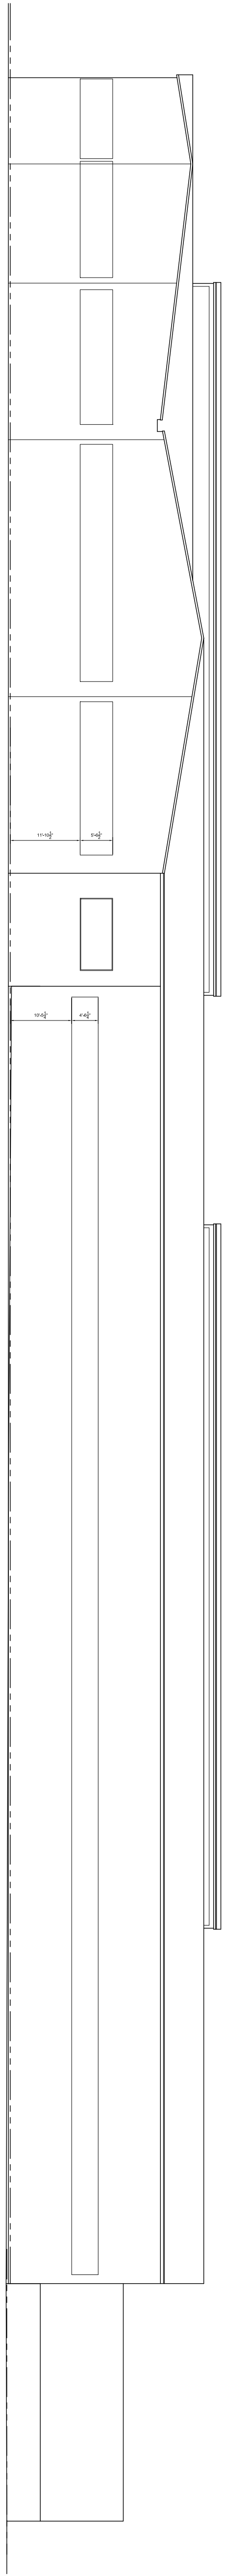


West Elevation (2)

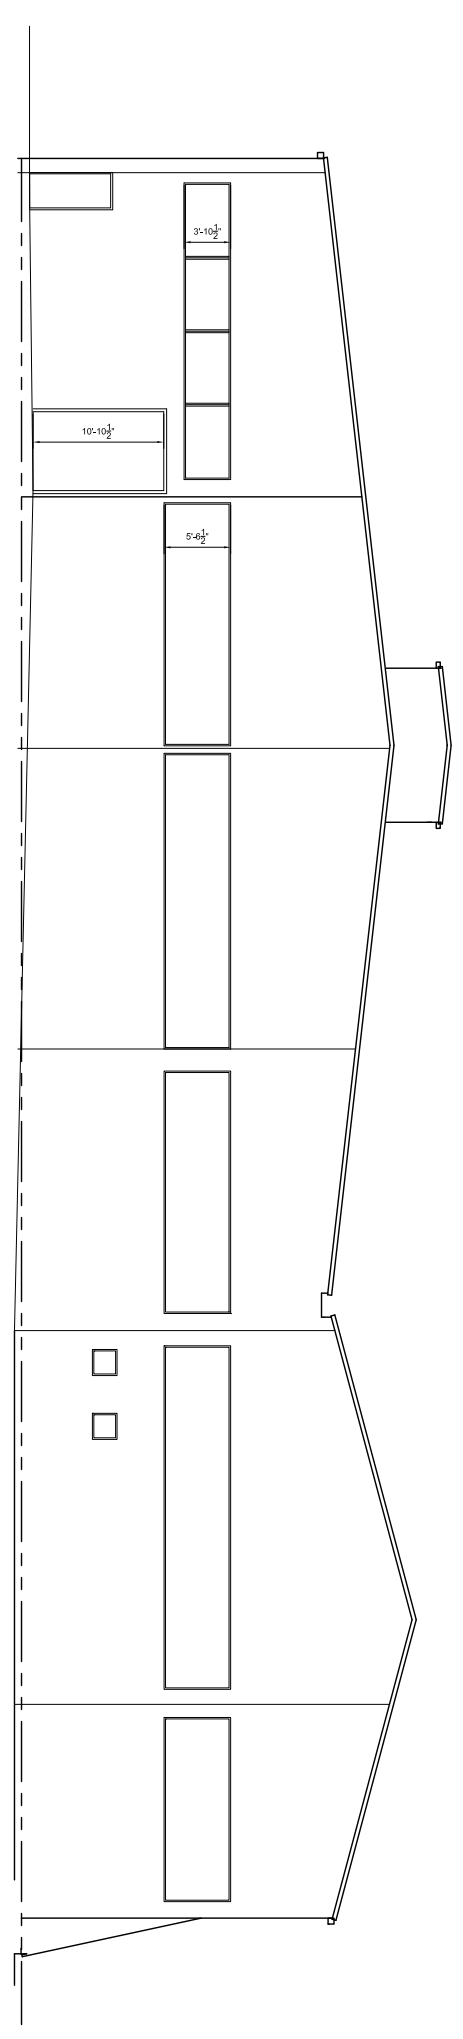


North Elevation (3)

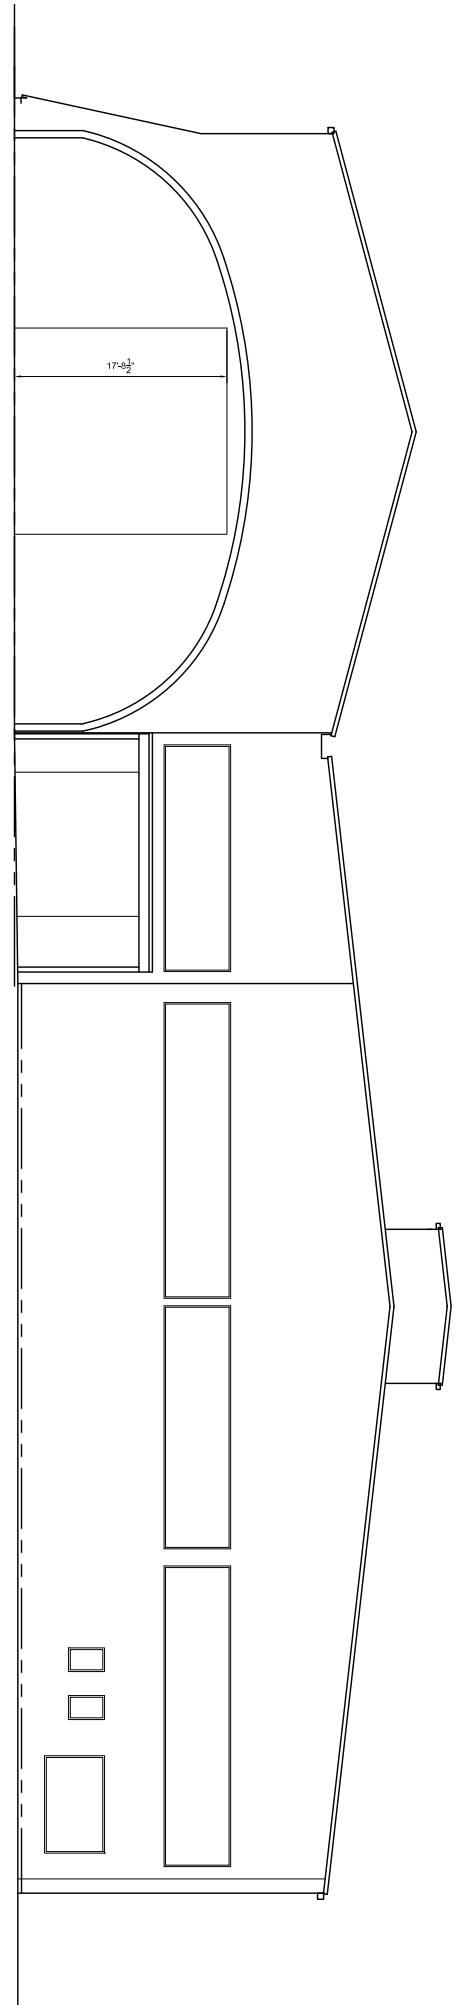

South Elevation (4)

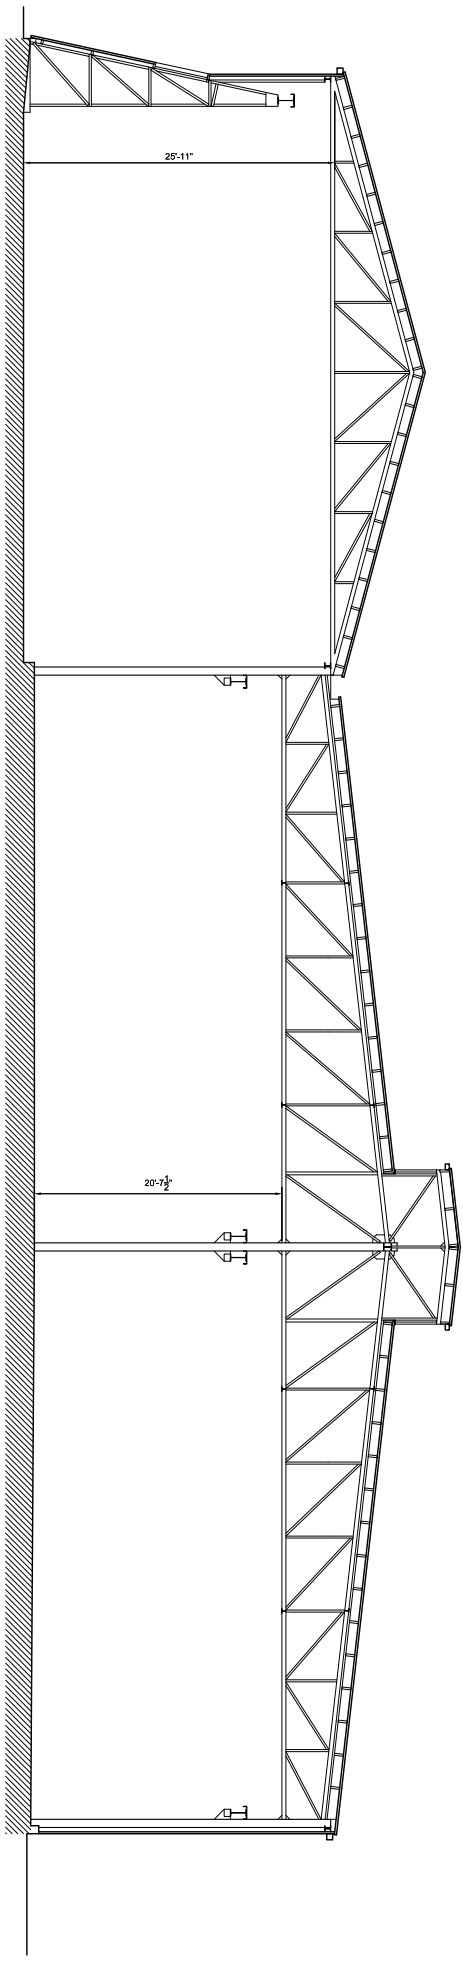

Section (5)

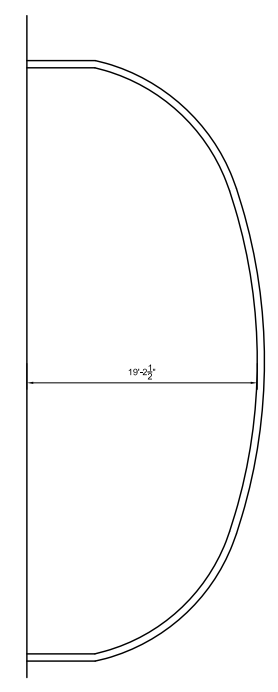

Section (6)

SHEET NO.
A-5.0
5 of 5 sheets

Date: 08/17/2015
 Drawn by: R. Wrightson
 T. Kelly, N. Dermand
 Approved by: M.C.
 Job Number: 1384-15
 File Name:
 205 S Mission.dwg

SHEET TITLE:
 Exterior Elevations & Sections

PROJECT INFO:
 205 S. Mission Road
 205 -251 S. Mission Road
 Los Angeles, CA 90033

CLIENT:
 3 STEEL LLC
 337 S. Andersen St.
 Los Angeles, CA 90033



PrecisionCAD
 354 South Spring Street, Suite 202
 Los Angeles, CA 90013
 213-620-0635
 info@precisioncad.net
 www.precisioncad.net